

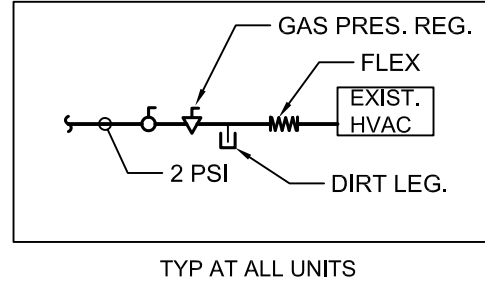


C:\10 Ben Ellis -\2015\10 of 0 942 Olive\1 Active Drawings\942 OLIVE - MP.dwg

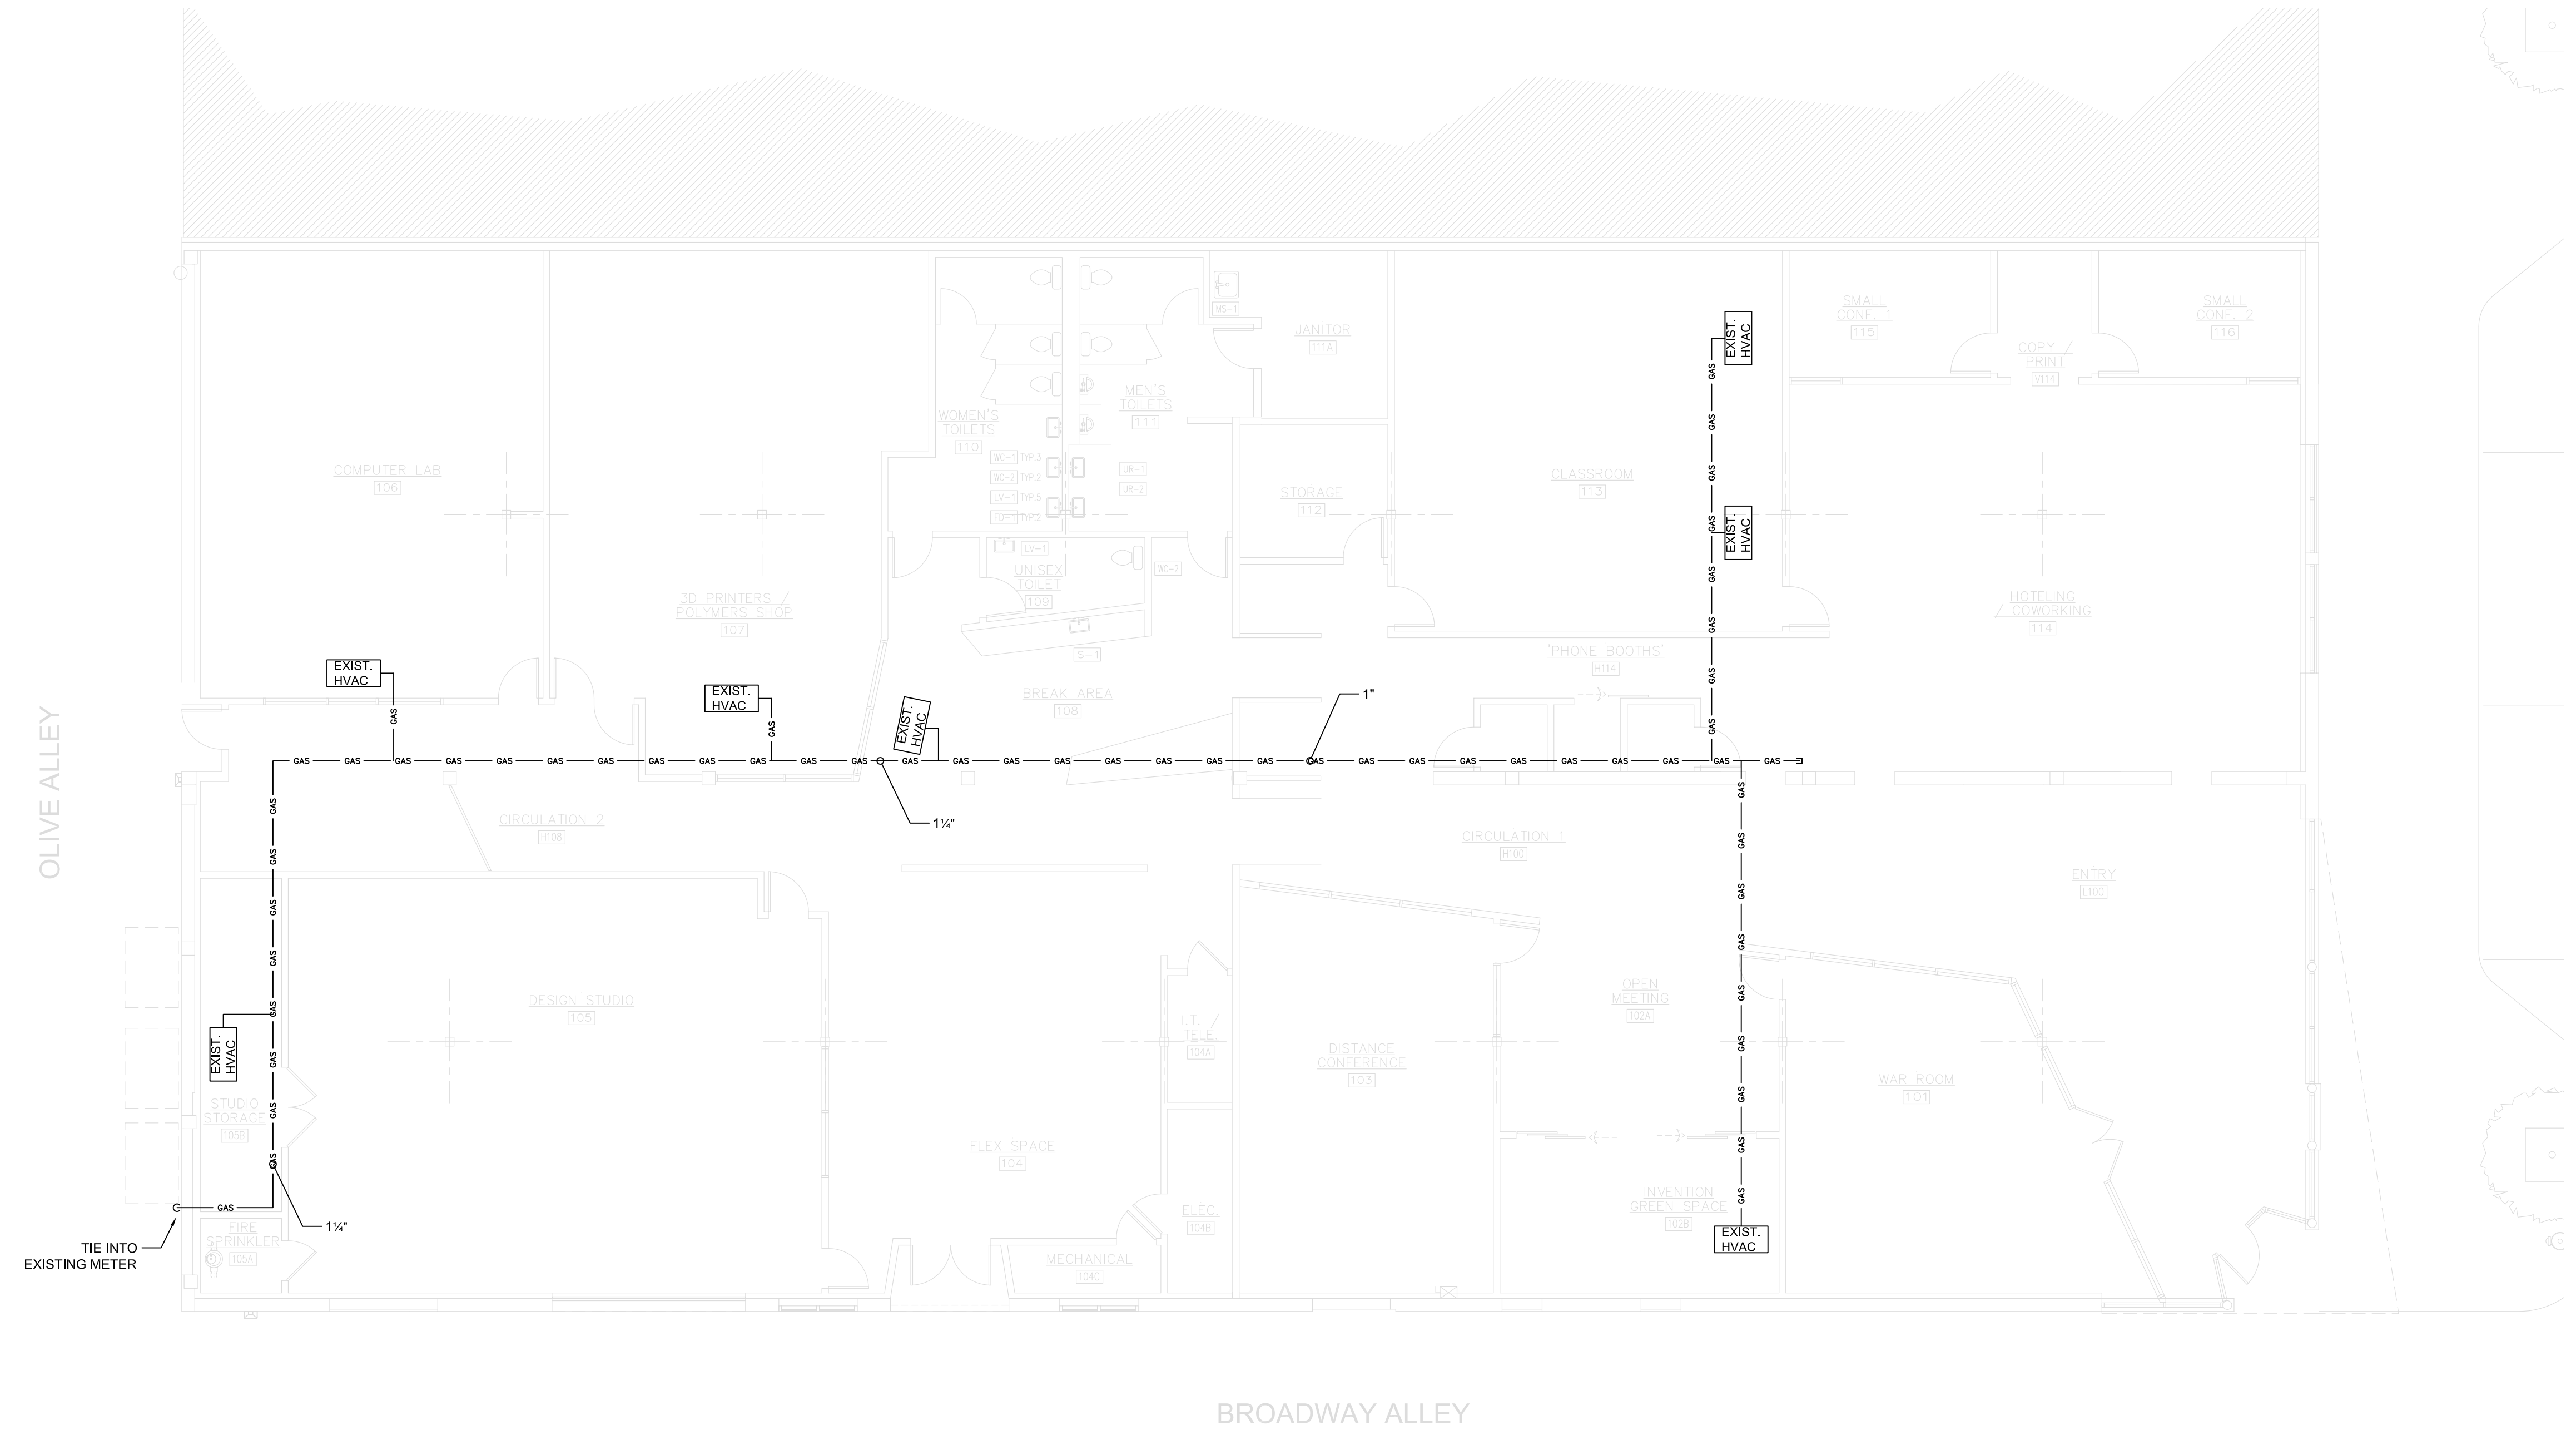

DETAIL WH-1
NTS

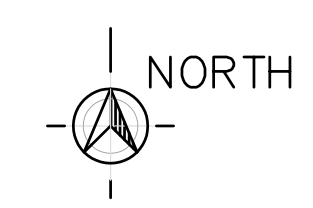

GAS PIPING PLAN
1/8" = 1'-0"


— GAS — GAS — GAS — GAS

CONSTRUCTION DOCUMENTS FOR THE:

942 OLIVE
EUGENE, OREGON

PROJECT NO.	70155
DRAWN	MJ
CHECKED	B.E.
DATE	9/18/15
REV. DATE	---

COPYRIGHT 2014, HARVEY & PRICE COMPANY. THE INFORMATION IS FOR YOUR USE ONLY AND SHALL NOT BE REPRODUCED, USED, OR DISCLOSED TO OTHERS EXCEPT AS AUTHORIZED BY THE WRITTEN PERMISSION OF HARVEY & PRICE COMPANY.

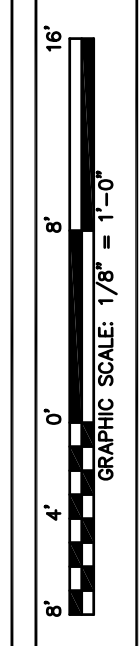

HARVEY & PRICE
2015 NUGGET WAY
EUGENE, OREGON 97403
(541) 746-1621
WWW.HARVEYANDPRICE.COM


© 2014

GAS
FIRST FLOOR
G.1
SHEET 2 OF 2


WSFU	HW
6 X W.C. = 2.5 EA.	15.0 0
2 X U.R. = 20, 15	35.0 0
6 X LAV = 1 EA	6.0 6.0
1 X S-1 = 2	2.0 2.0
1 X MS-1 = 3.0	3.0 3.0
3 X HB = 2.5 PER 1 PLUS 1.0 EA. ADD.	4.5 0
2 X ICE/COFFEE WALL BOX 0.5 EACH =	1.0 0
	66.5 WSFU TOTAL
	11.0 HOT WSFU

DISTANCE - 155' TDL
DEMAND - 66.5 WSFU
ELEVATION - 4'
PRESSURE - 80 PSI

MAX WSFU
1/2" PIPE - 85
3/4" PIPE - 62
1" PIPE - 32
1 1/2" PIPE - 13
2" PIPE - 4

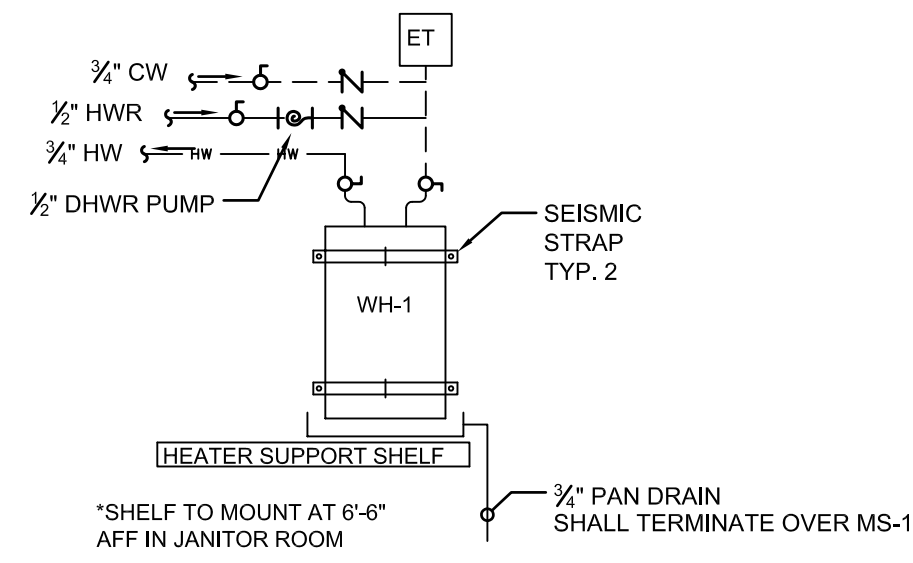


DETAIL WH-1
NTS

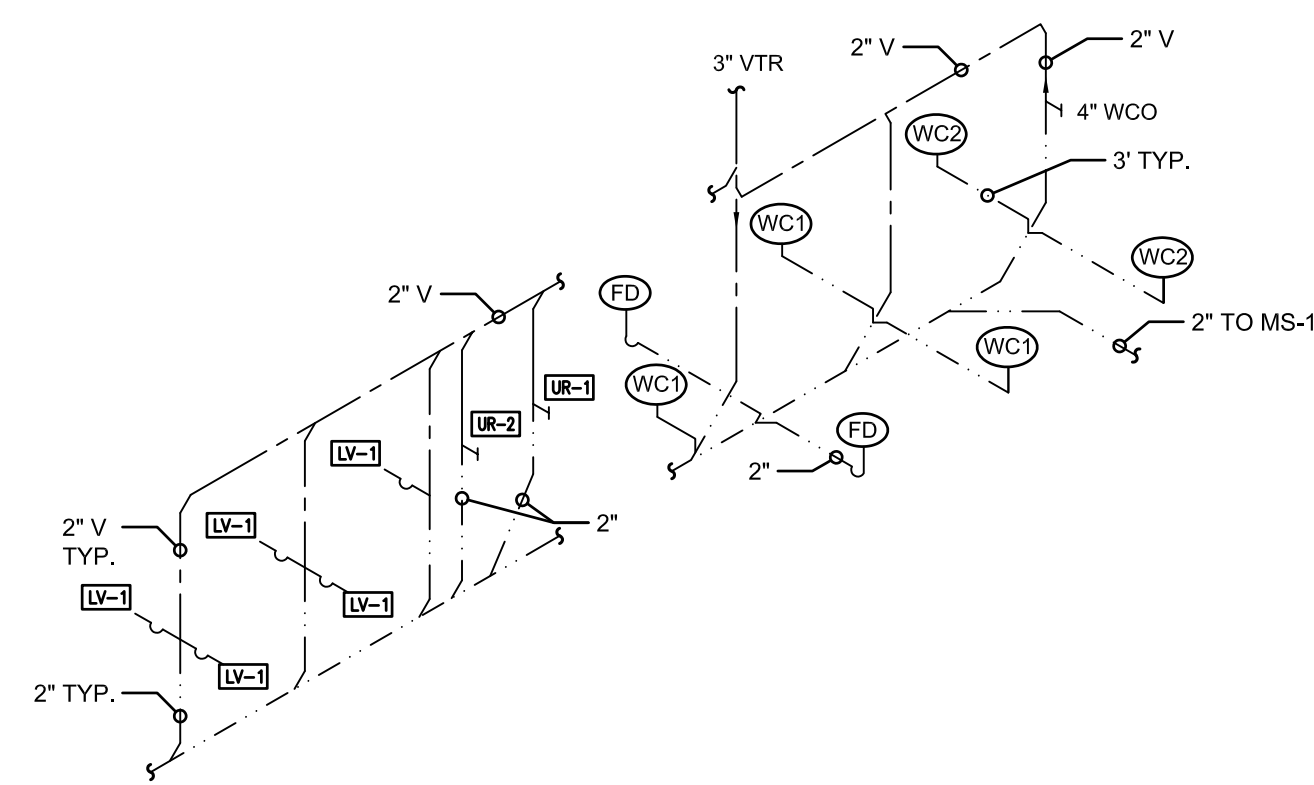

NORTH
RESTROOM DWV ISOMETRIC
NTS

FIXTURE SCHEDULE	
WC-1	STD.TANK, AIR, F.M.
WC-2	ADA TANK, AIR, F.M.
UR-1	(STD) FLUSHOMETER - WALL
UR-2	(ADA) FLUSHOMETER - WALL
LV-1	DROP-IN LAV.
S-1	SINK
MS-1	MOP SINK
FD	FLOOR DRAIN
FCO	FLOOR CLEAN-OUT
WCO	WALL CLEAN-OUT
HB	HOSE BIBB - FROST PROOF
P-1	PRIMER
WH-1	30 GAL. ELECT. WATER HEATER
ET-	1 GAL. EXP. TANK
DHWR-PUMP	1/2" CIRC. PUMP

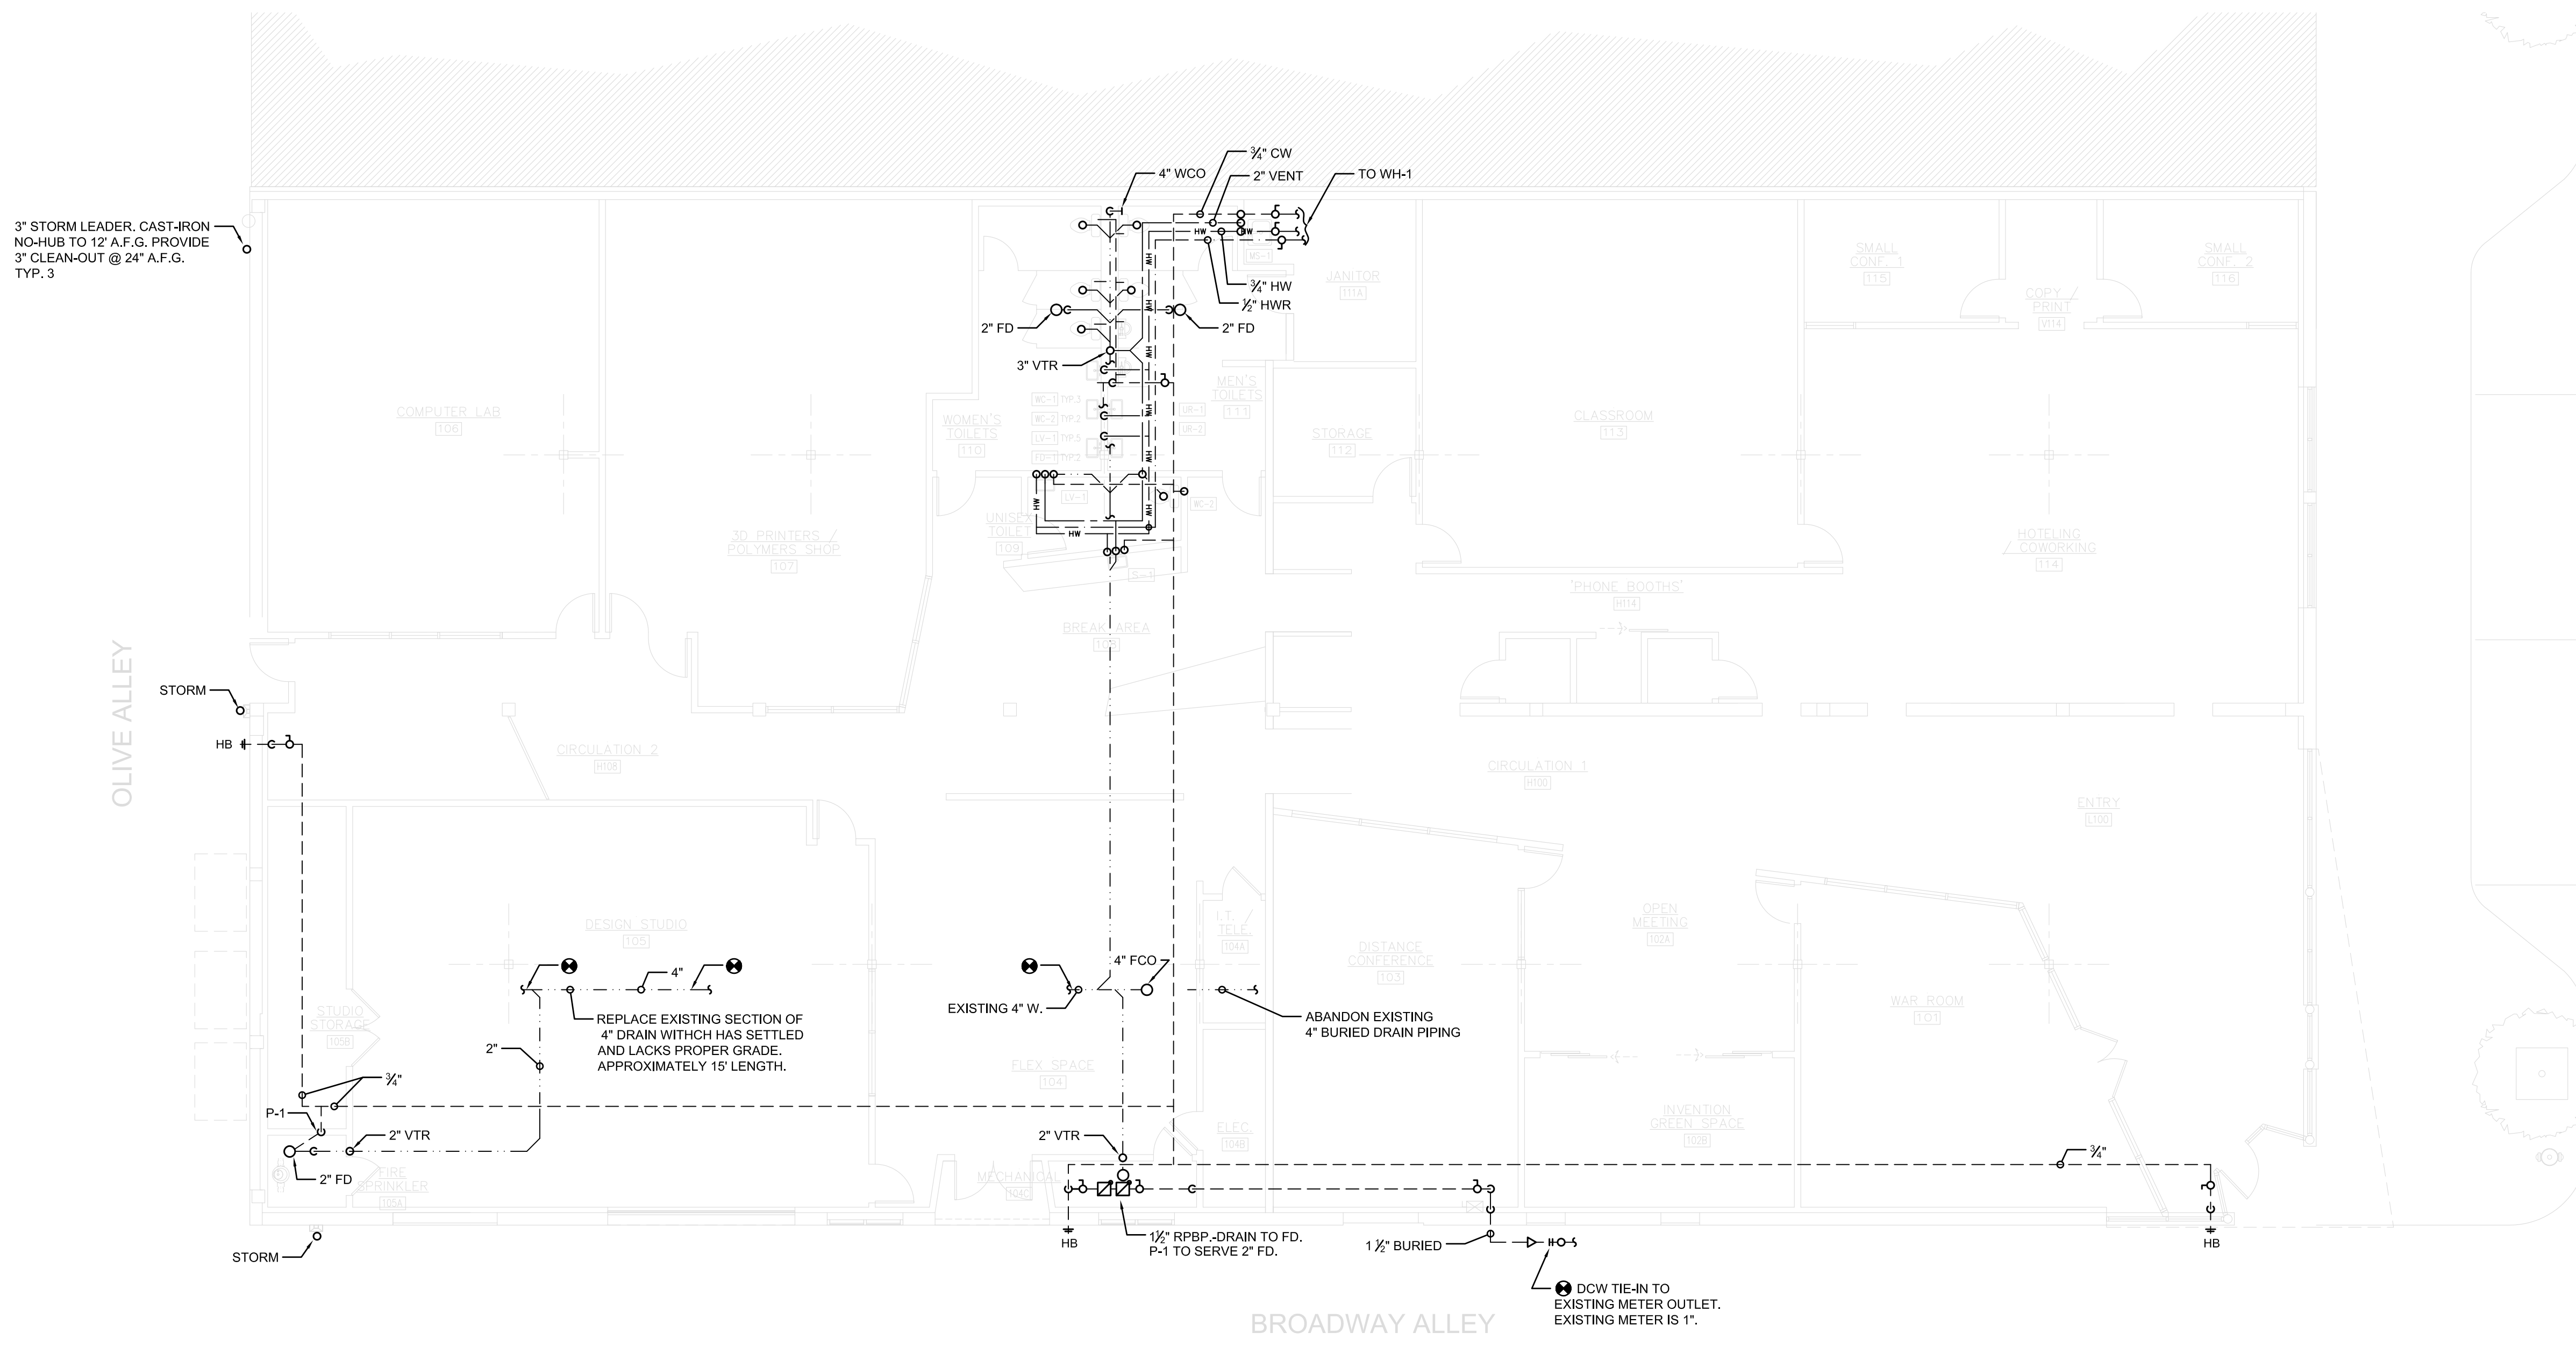

NORTH
PLUMBING PIPING PLAN
1/8" = 1'-0"

---	DOMESTIC COLD WATER - CW
---	DOMESTIC HOT WATER - HW
---	DOMESTIC HOT WATER RECIRC. - HWR
---	SANITARY WASTE
---	SANITARY VENT
○	BALL VALVE
○	CHECK VALVE

HARVEY & PRICE
2015 NUGGET WAY
EUGENE, OREGON 97403
(541) 748-1621
WWW.HARVEYANDPRICE.COM



COPYRIGHT 2014, HARVEY & PRICE COMPANY.
THIS DRAWING IS THE PROPERTY OF HARVEY & PRICE COMPANY AND SHALL NOT BE REPRODUCED, USED, OR DISCLOSED TO OTHERS EXCEPT AS AUTHORIZED BY THE WRITTEN PERMISSION OF HARVEY & PRICE COMPANY.

CONSTRUCTION DOCUMENTS FOR THE:
942 OLIVE
EUGENE, OREGON

PROJECT NO. 70155
DRAWN MJ
CHECKED B.E.
DATE 9/18/15
REV. DATE